




ANSCHLUSS 10: "KOND. GOETHE", GOETHE STRASSE 11
ALLACCIO 10: "COND. GOETHE", VIA GOETHE 11

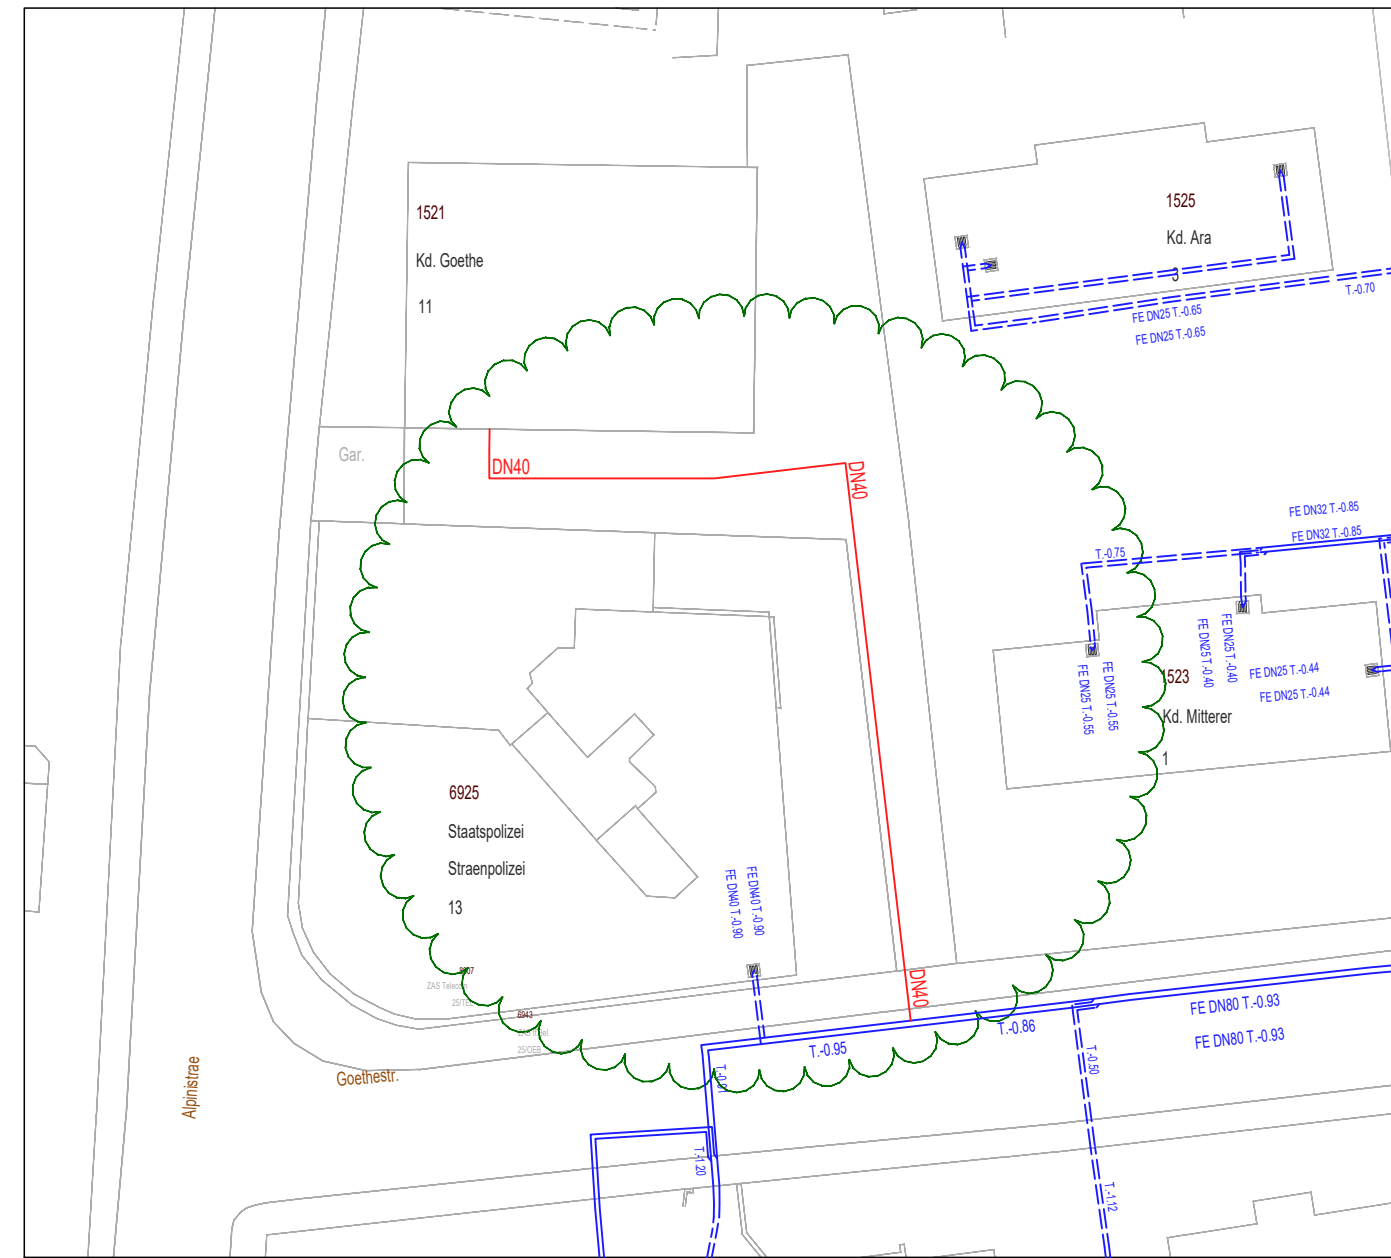


ANSCHLUSS 11: "B. FISCHNALLER", ELVASERSTRASSE 47/A, KRANEBITT
ALLACCIO 11: "B. FISCHNALLER", VIA ELVAS 47/A, COSTA D'ELVAS

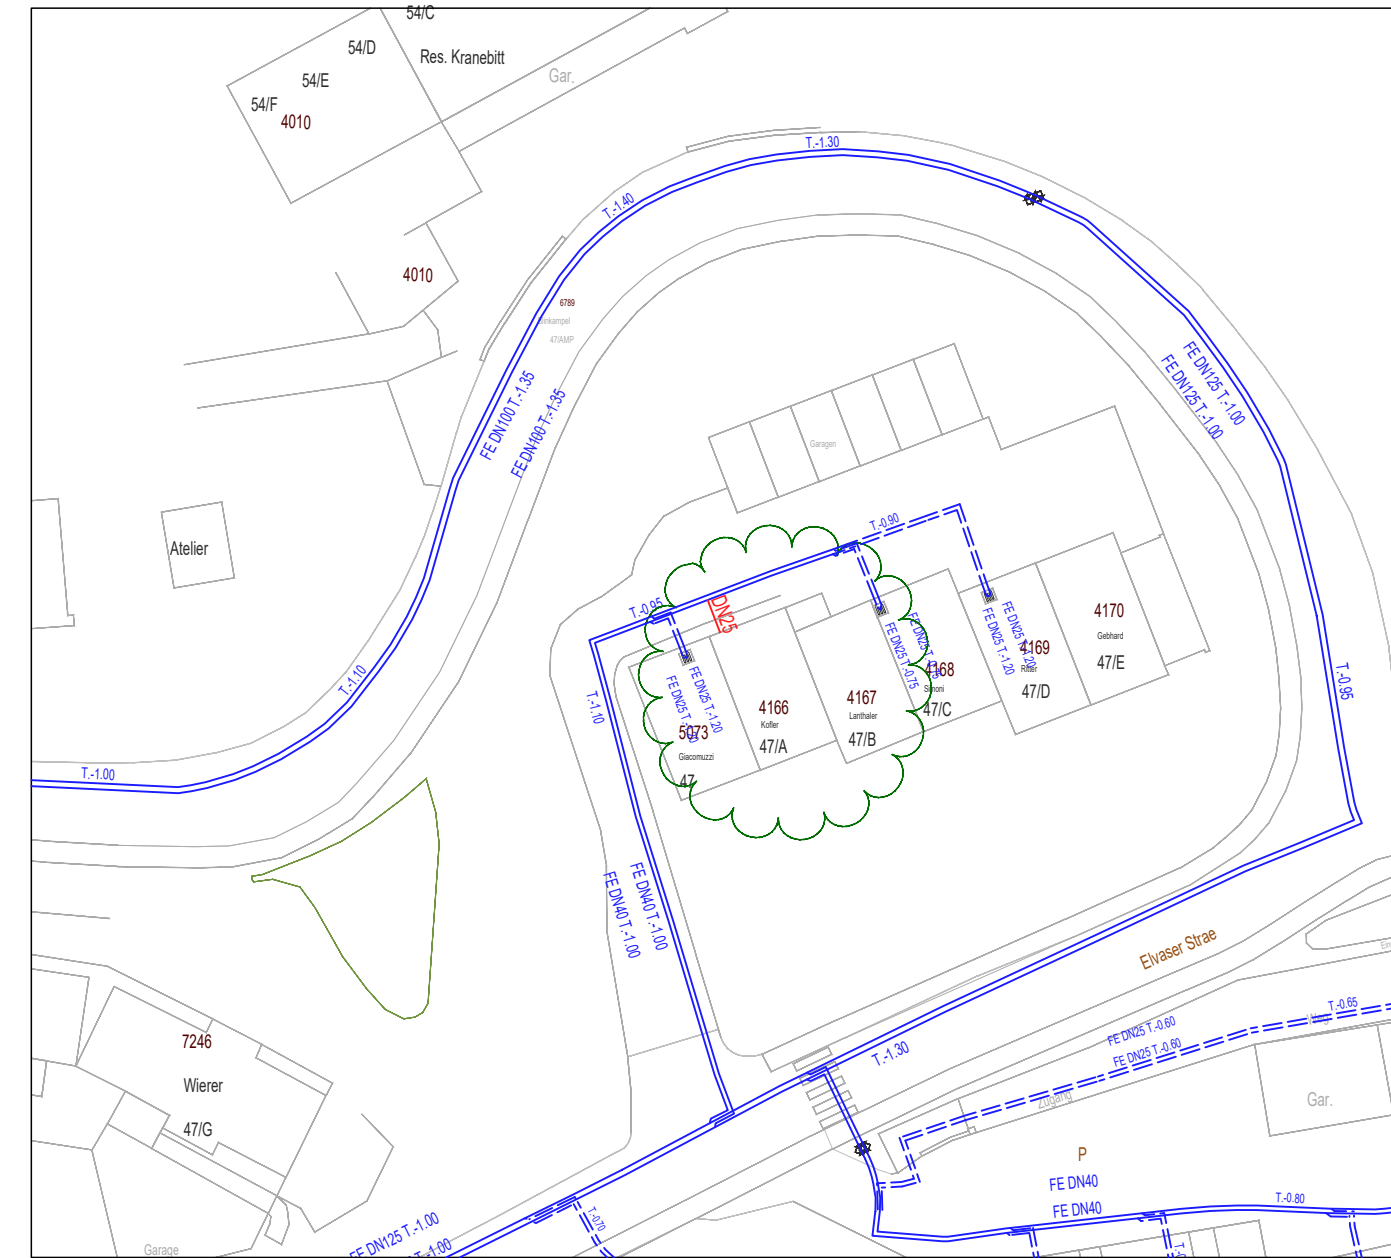

ANSCHLUSS 12: "N. RITSCH", RECHTER EISACKDAMM 12
ALLACCIO 12: "N. RITSCH" LUNGO ISARCO DESTRO 12

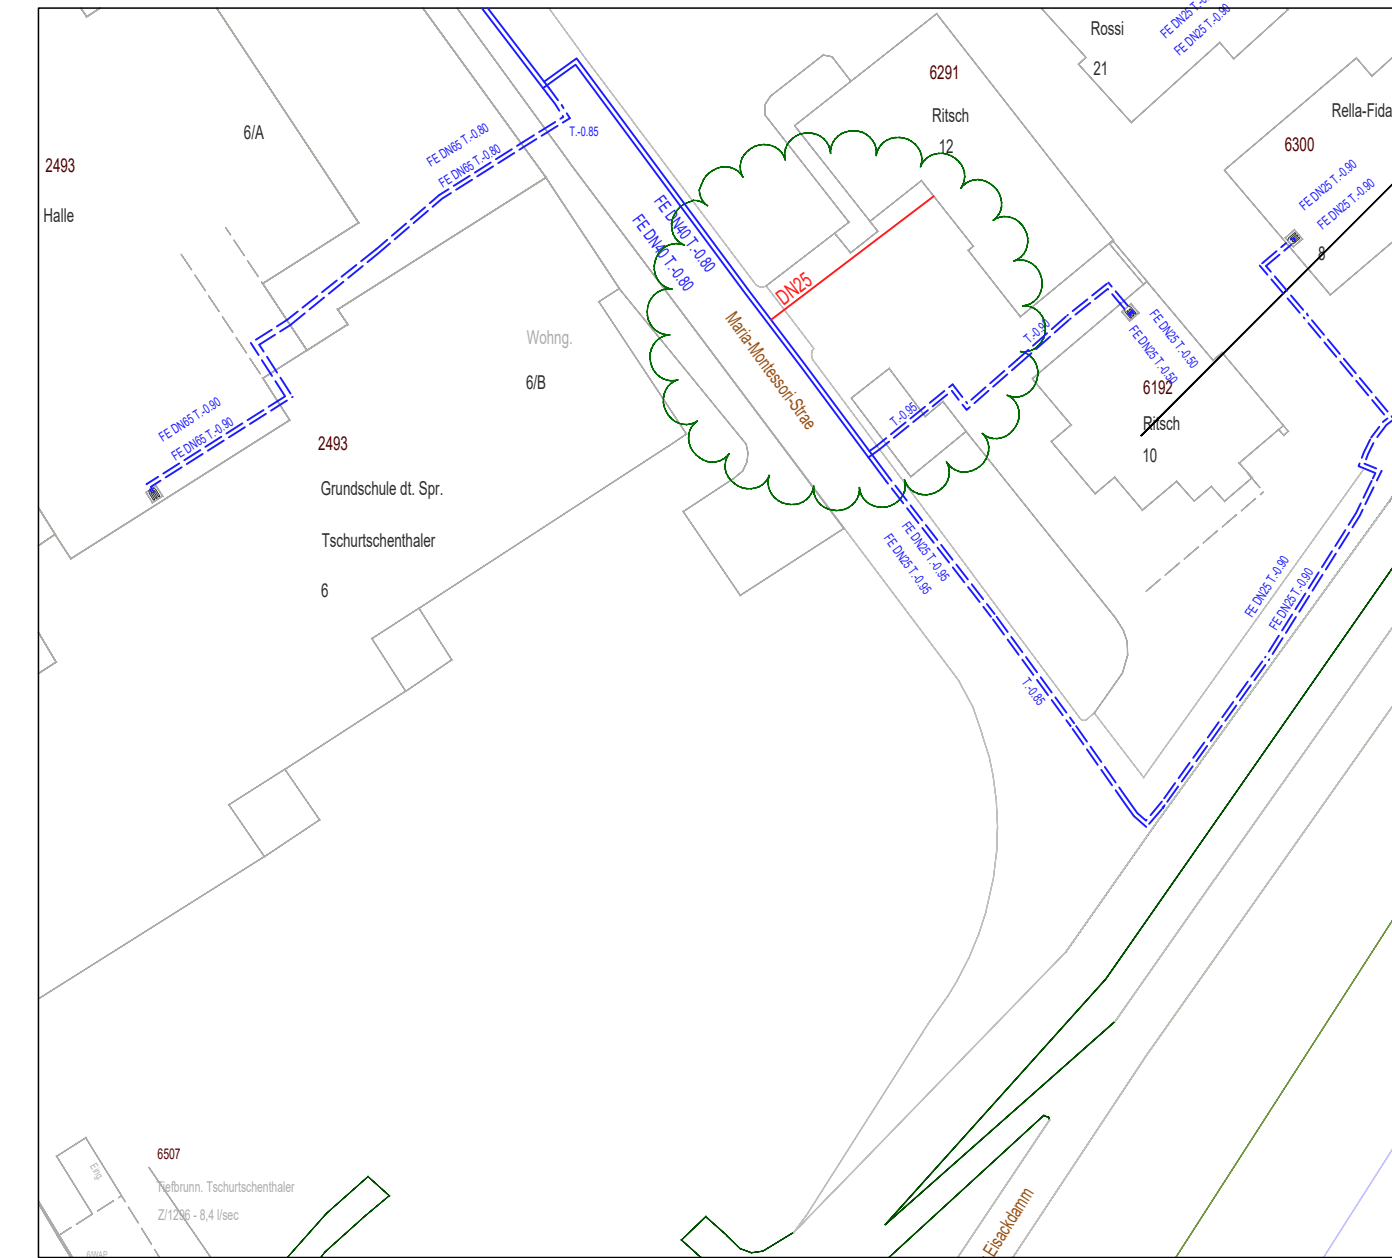


ANSCHLUSS 13: "NEUBAU BERBACHER", OBERE SCHUTZENGELGASSE 18
ALLACCIO 13: "NUOVA COSTRUZIONE BERBACHER", VIA ANGELO CUSTODE 18

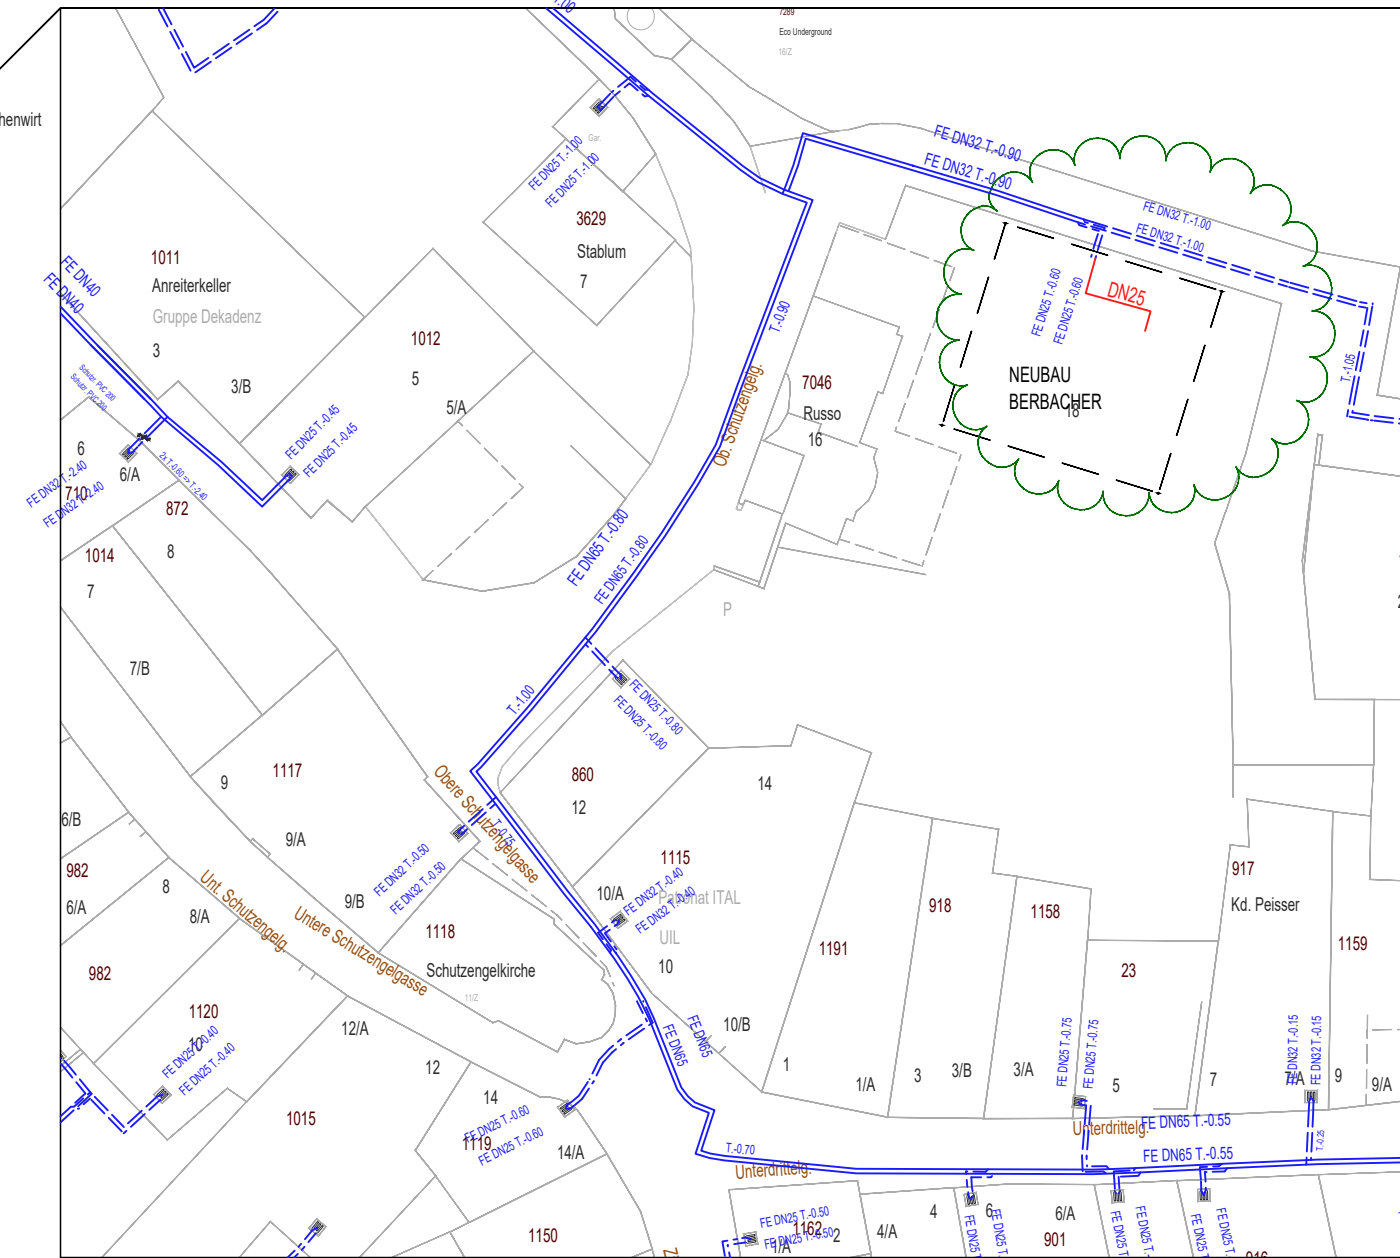


ANSCHLUSSE 14 - 15: "PROSCH, HINTEREGGER", PLATSCHWEG 38 u. 40
ALLACCIO 14 - 15: "PROSCH, HINTEREGGER", VIA PLATSCH 38 e 40



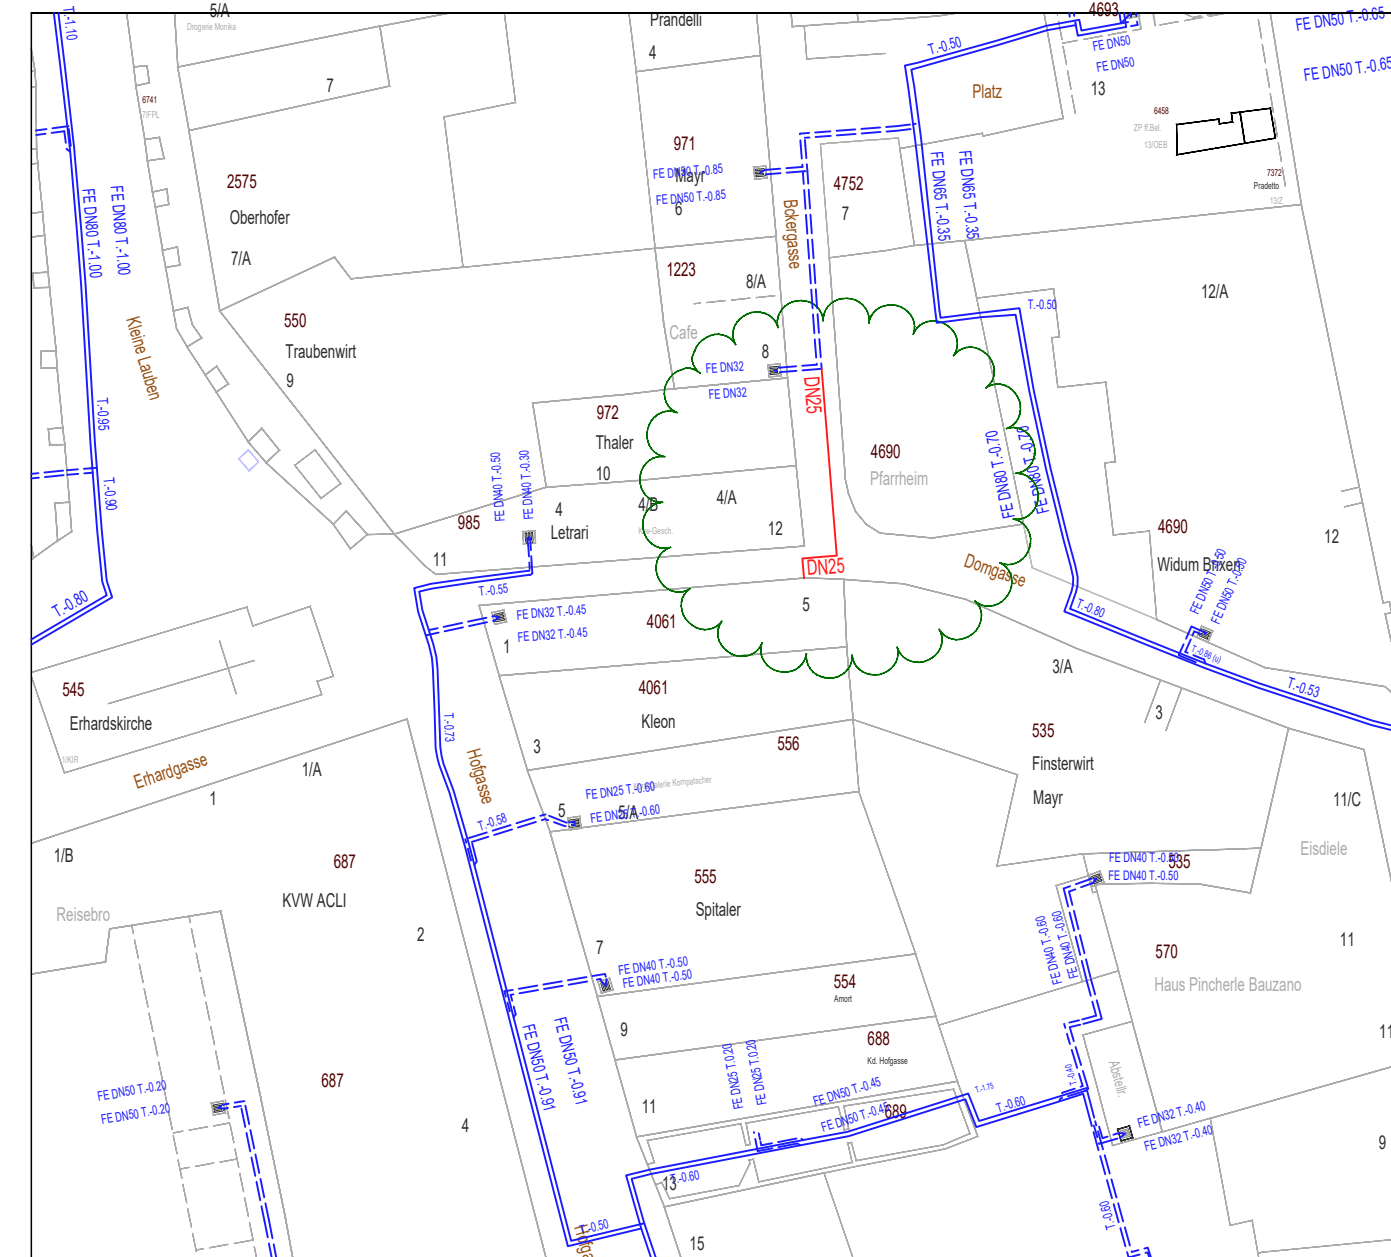


ANSCHLUSS 16: "M. KLEON", DOMGASSE 5
ALLACCIO 16: "M.KLEON", VIA DUOMO 5

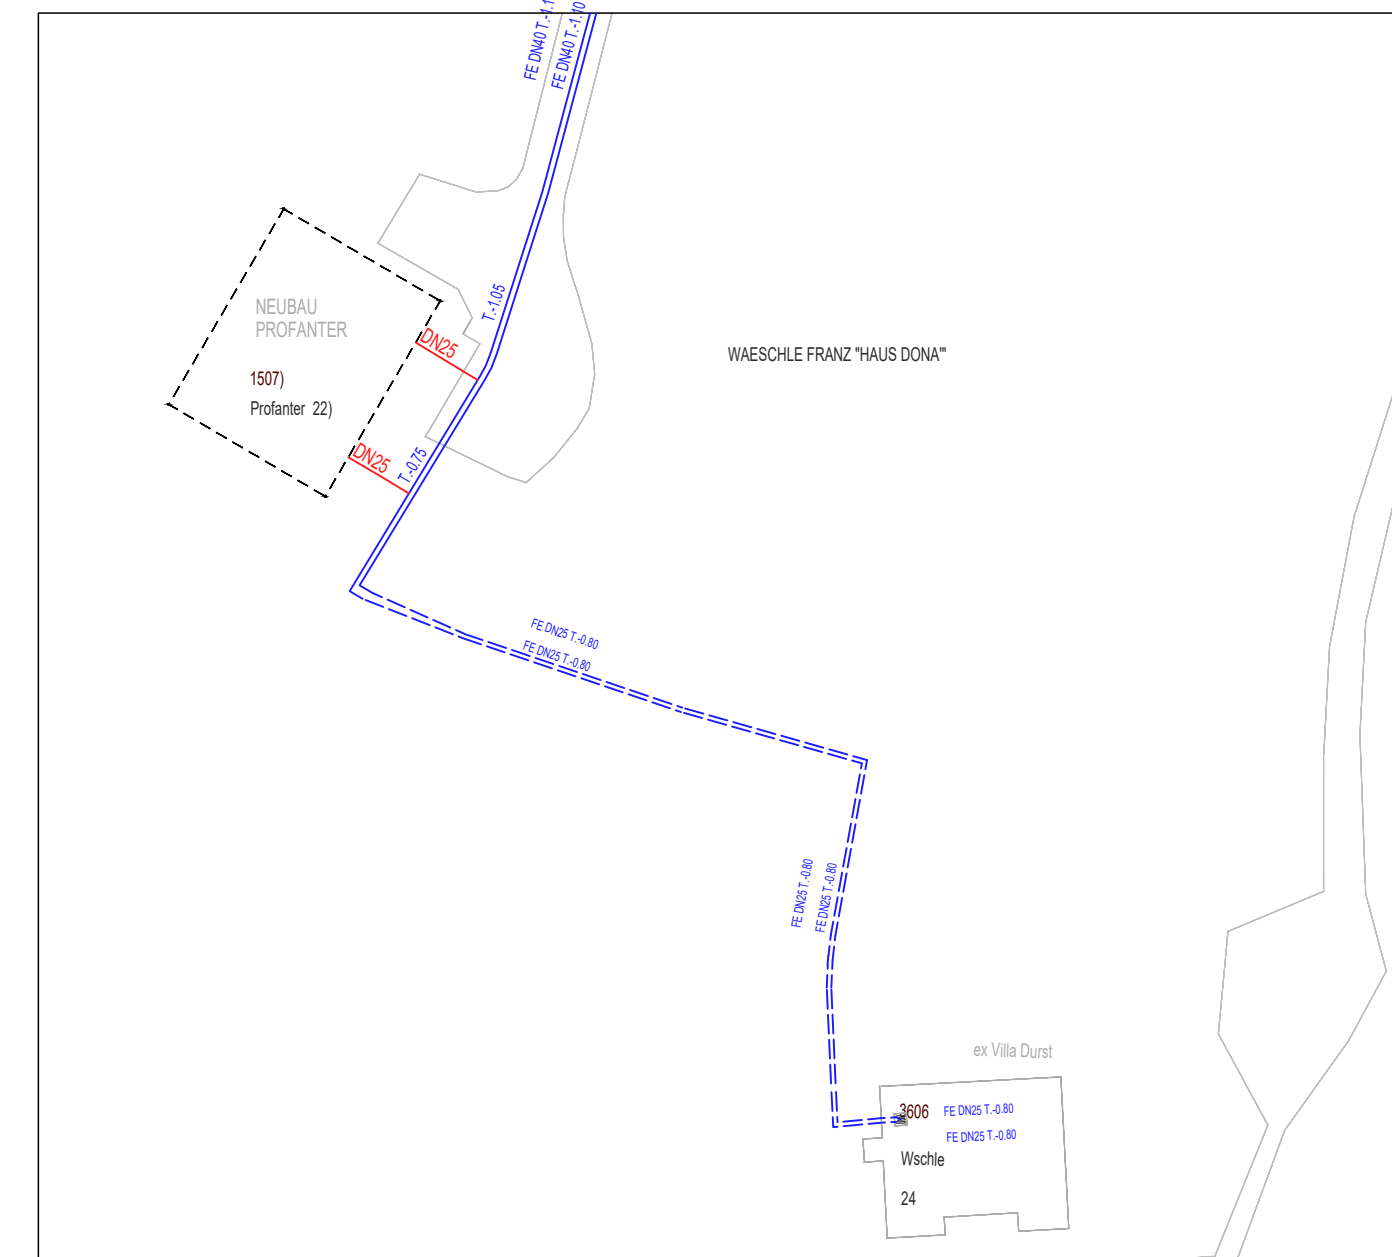


ANSCHLUSSE 17: "PROFANTER", LEONHARDERSTRASSE, ST. ANDR
ALLACCI 17: "PROFANTER", VIA S. LEONARDO, S. ANDREA



LEGENDE / LEGENDA

-  BESTEHENDE FERNWÄRMELEITUNG TUBAZIONE TLR ESISTENTE
-  TRASSE FERNWÄRMELEITUNG IN PLANUNG TRACCIATO TUBAZIONE TLR IN PROGETTO
-  FW- ANSCHLUSS IN PLANUNG ALLACCIO TLR IN PROGETTO

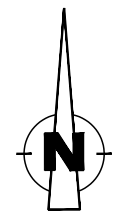

Provincia di Bolzano

Gemeinde Brixen
Comune di Bressanone

stadtwerke asm
 BRIXEN | BRESSANONE
 Stadtwerke Brixen AG/ASM Bressanone Spa
 I-39042 Brixen/Bressanone Via Alfred-Amonn-Strasse 24
 Tel. +39 0472 823 500 Fax +39 0472 823 666
 mail@asm.it www.asm.it

Projekt / Progetto:

**FERNWÄRMEVERSORGUNG DER STADT BRIXEN
 Teleriscaldamento Città di Bressanone**

FERNWÄRME- NETZVERDICHTUNG 2021- 2024
 und Erneuerung weiterer Infrastrukturen

AMPLIAMENTO RETE DI Teleriscaldamento 2021- 2024
 e rinnovo di ulteriori infrastrutture

AUSFÜHRUNGSPROJEKT / PROGETTO ESECUTIVO

Inhalt / Contenuto:

**LAGEPLAN 2 FW- HAUSANSCHLÜSSE
 PLANIMETRIA 2- ALLACCIAMENTI TLR**

Bauherr
Committente
Dr. Ing. Karl Michaeler

Projektant
Progettista
Dr. Ing. Christian Kerschbaumer

0	25.02.2021	1. Ausgabe / 1ª edizione	C.K.	C.K.
Rev.	Datum / Data	Ausgabe - Änderung / Edizione - modifica	erstellt / elab.	geprüft / esam.
Projekt Nr. / progetto n° FZ28	Bauftrag Nr. / Ordine n° FZ28	Maßstab / Scala 1:500	Nr. P02	